


- NOTES:
1. E-EGRESS WINDOW LOCATION
  2. H-65K BTU FLOOR MOUNT HEATER
  3. GO ES 3PT DOUBLE
  4. V- 3PT GRAB HANDLE

REV	DATE	BY	CHKD	APP'D	DESCRIPTION
A	10/19/23	MNF			MOVED OH GRAB RS TO CS

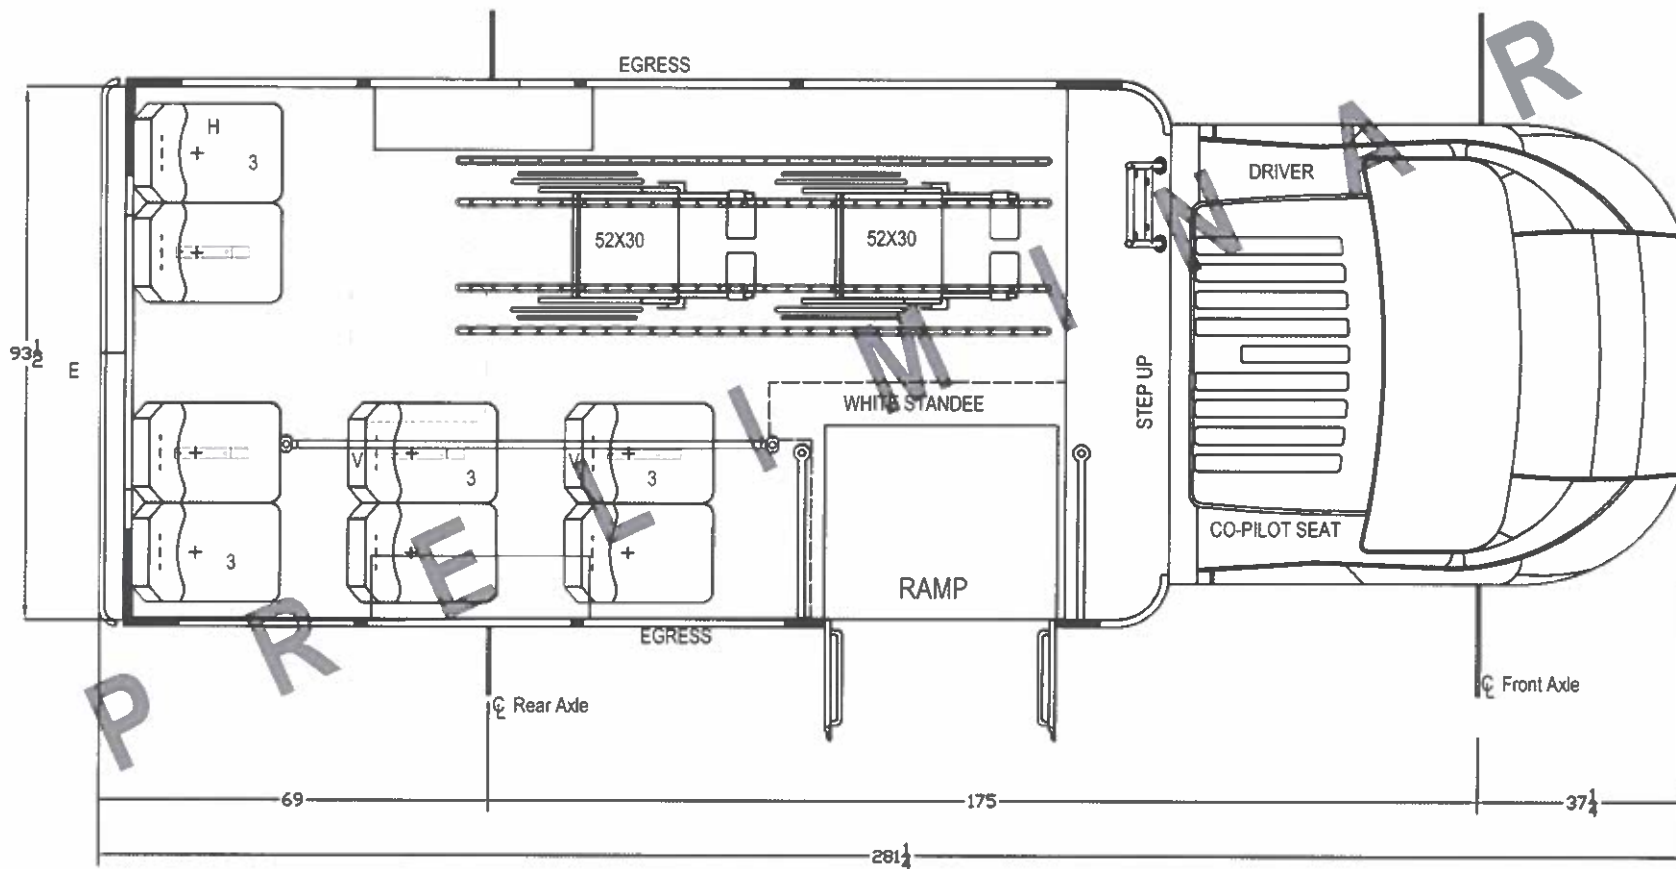

ARBOC SPECIALTY VEHICLES CLAIMS PROPRIETARY RIGHTS IN THE MATERIAL DISCLOSED HEREON. NEITHER THIS DRAWING NOR ANY REPRODUCTION THERE OF MAY BE USED TO MANUFACTURE ANYTHING SHOWN HEREON WITHOUT PERMISSION IN WRITING FROM ARBOC SPECIALTY VEHICLES TO THE USER SPECIFICALLY REFERRING TO THE DRAWINGS. INFORMATION CONTAINED HEREON MAY BE THE EXPRESS PROPERTY OF ARBOC SPECIALTY VEHICLES AND PROTECTED IN THE FORM OF A U.S. PATENT.

TOLERANCES:  
 FLOOR PLAN DIMS: ± 1/8"  
 FRACTIONAL DIMS: ± 1/16"  
 2 PLACE DECIMAL DIMS: ± .01"  
 3 PLACE DECIMAL DIMS: ± .005"

NAME: FLOOR PLAN, 8PS-2VC-175G-SQ1-P					
DRAWN BY:	DATE	DRAWING NUMBER:	REVISION:	SHEET	
MNF	10/17/23	1207550	A	1	OF 2